




MAINTENANCE SHOP - NAVCAMS BARRIGADA

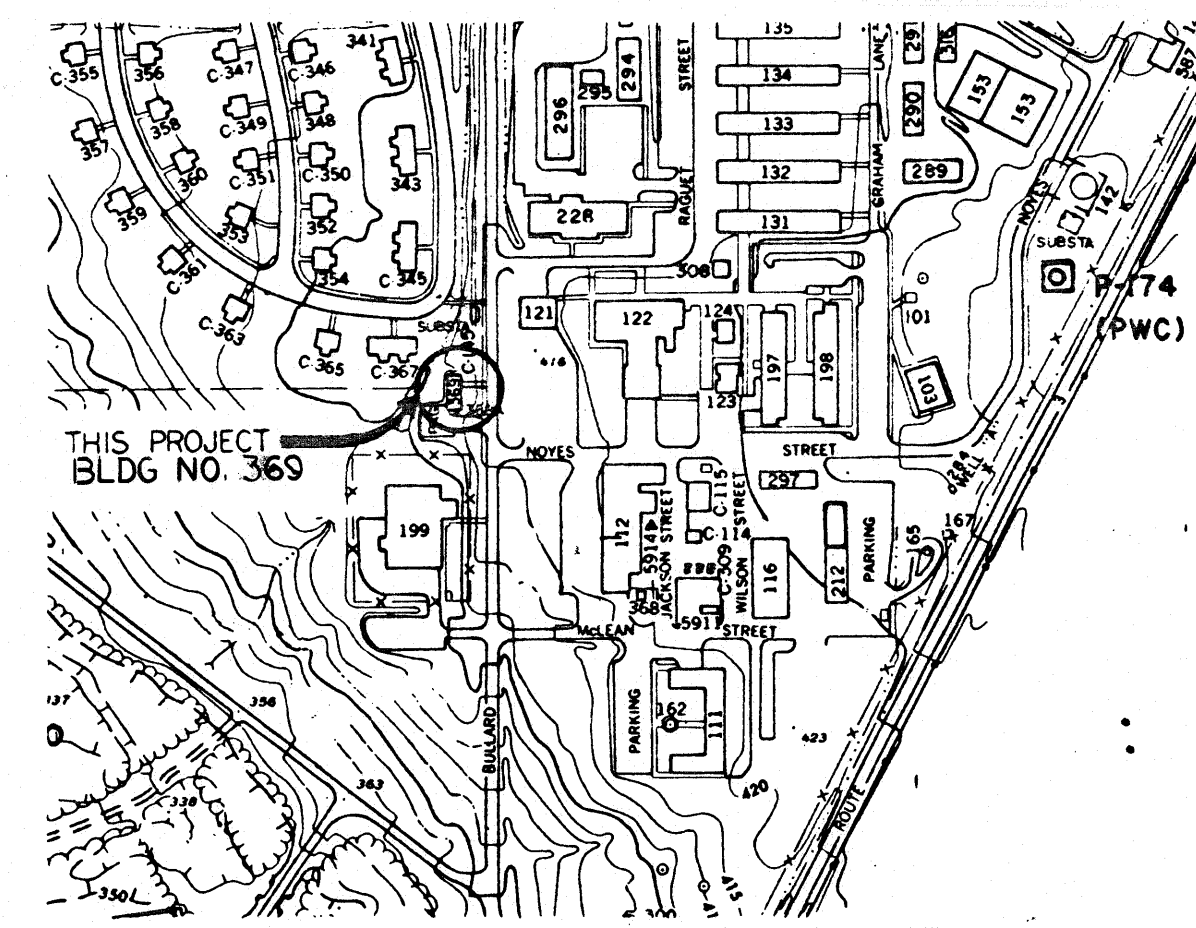


TELEPHONE EXCHANGE - NAVCAMS FINEGAYAN

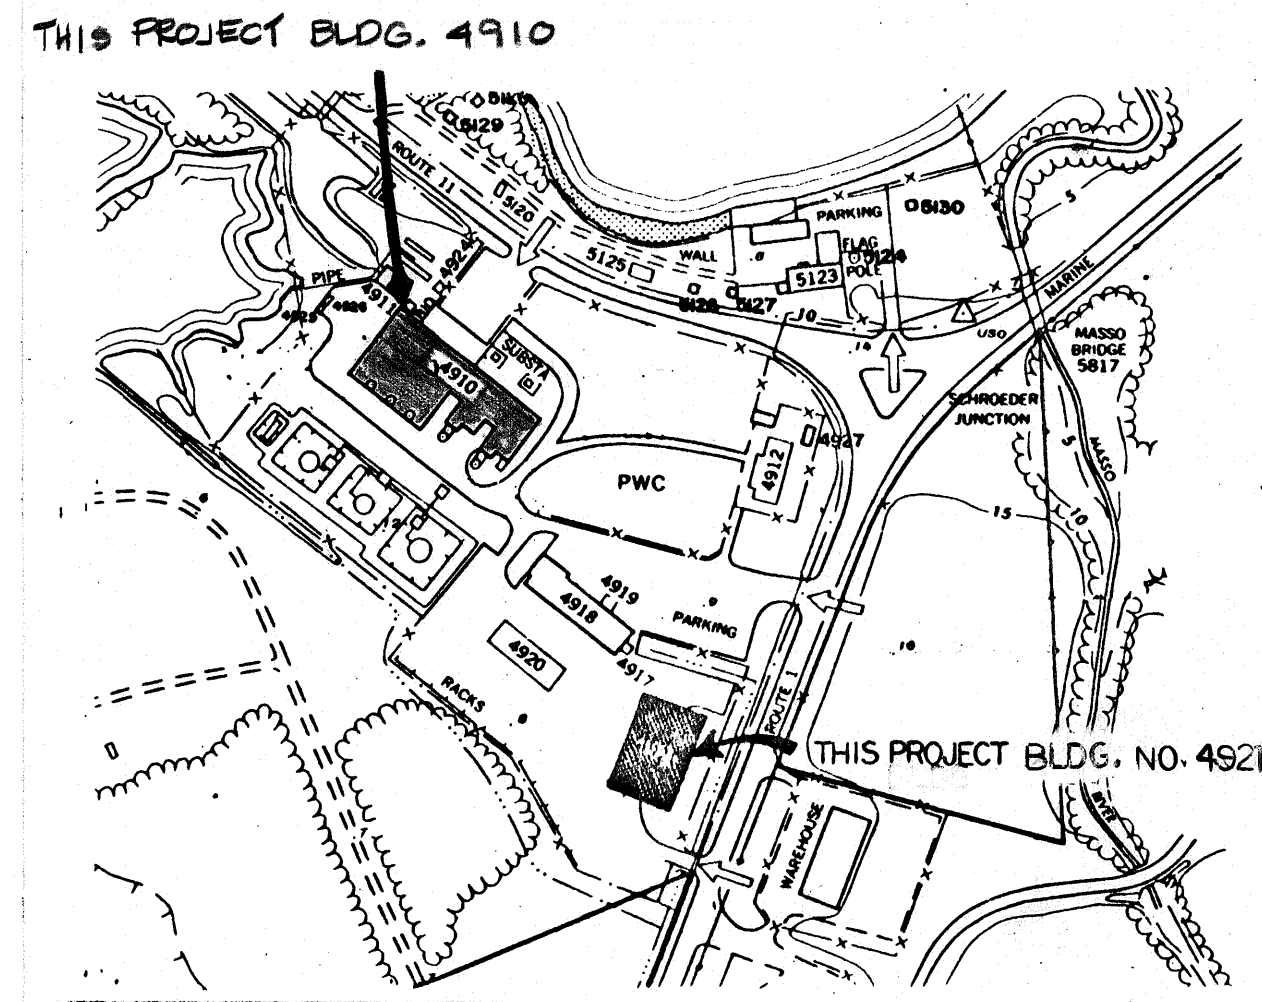


UTILITIES SHOP STORAGE - PIT

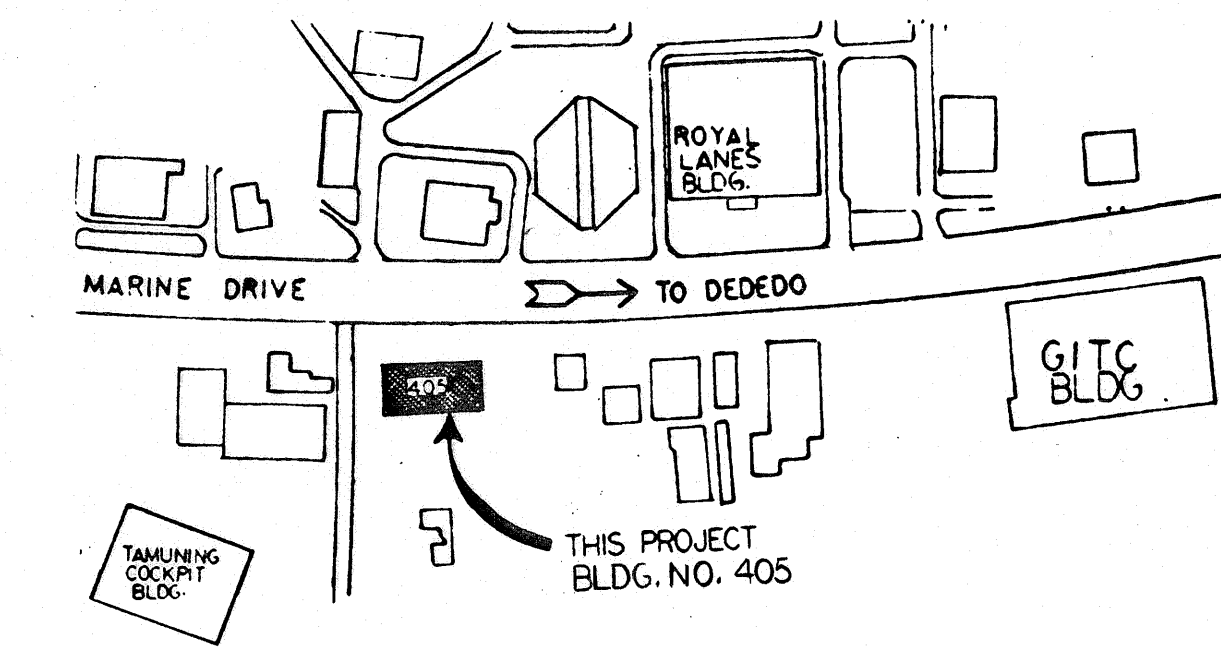


TELEPHONE EXCHANGE - TAMUNING

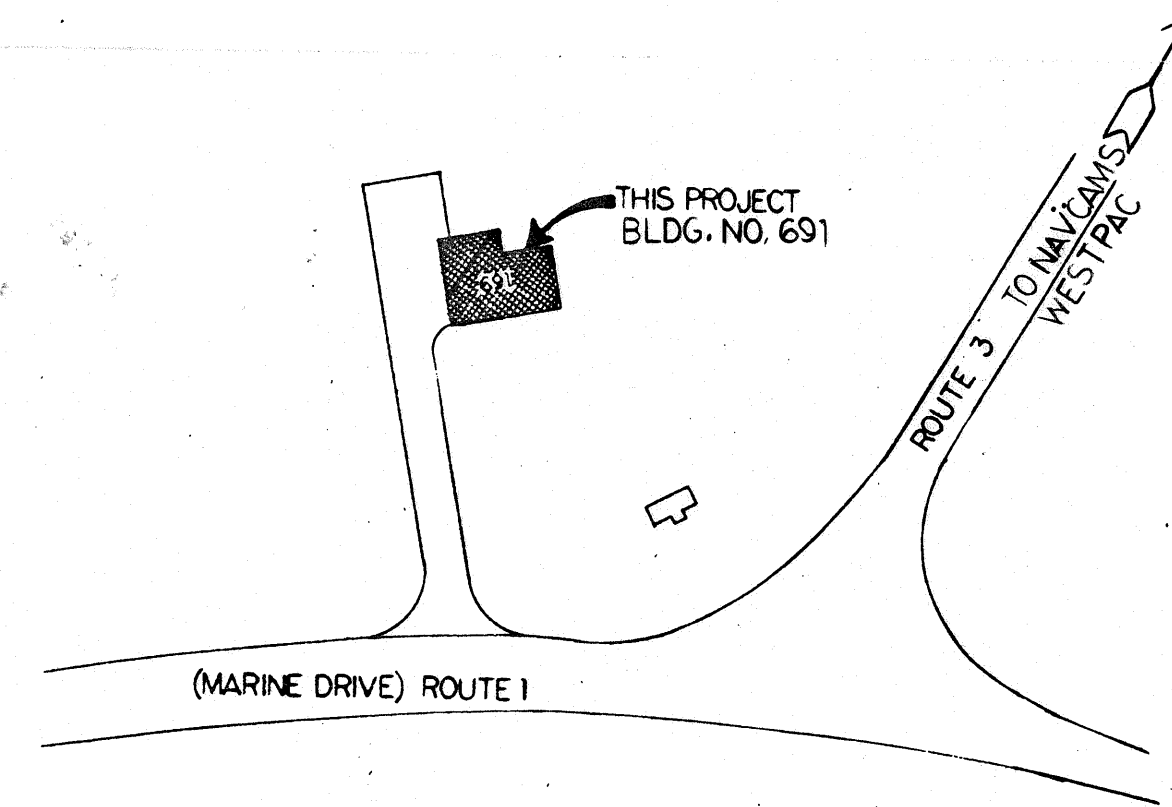


TELEPHONE EXCHANGE - HARMON

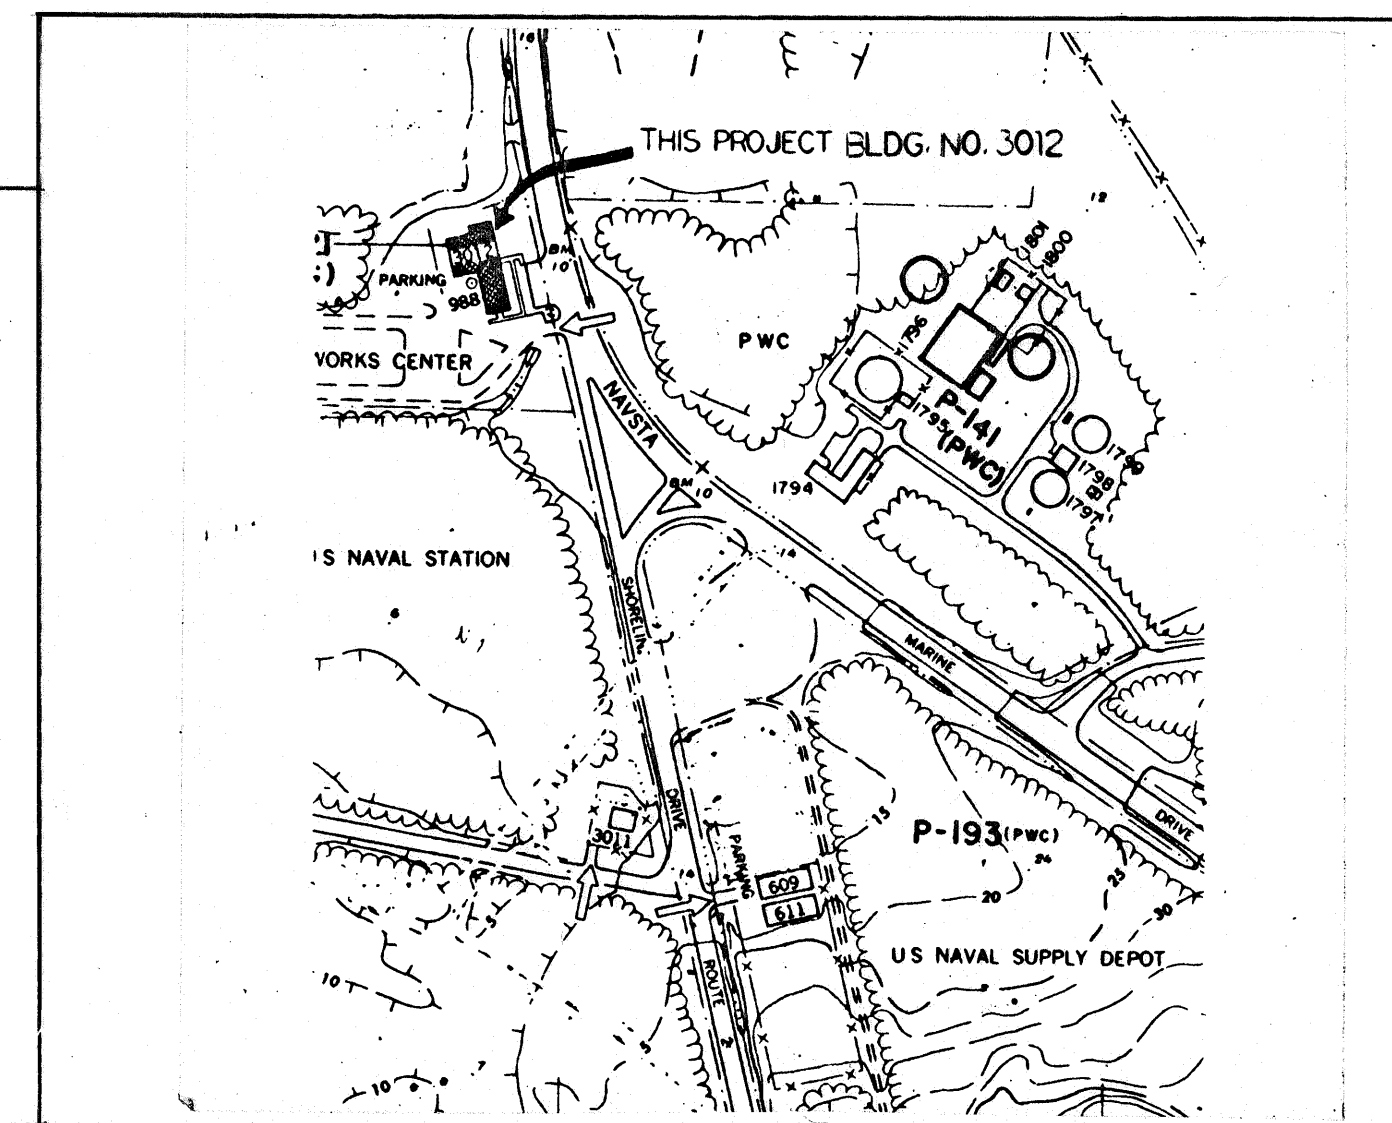


TELEPHONE EXCHANGE - OROTE NAVAL STATION

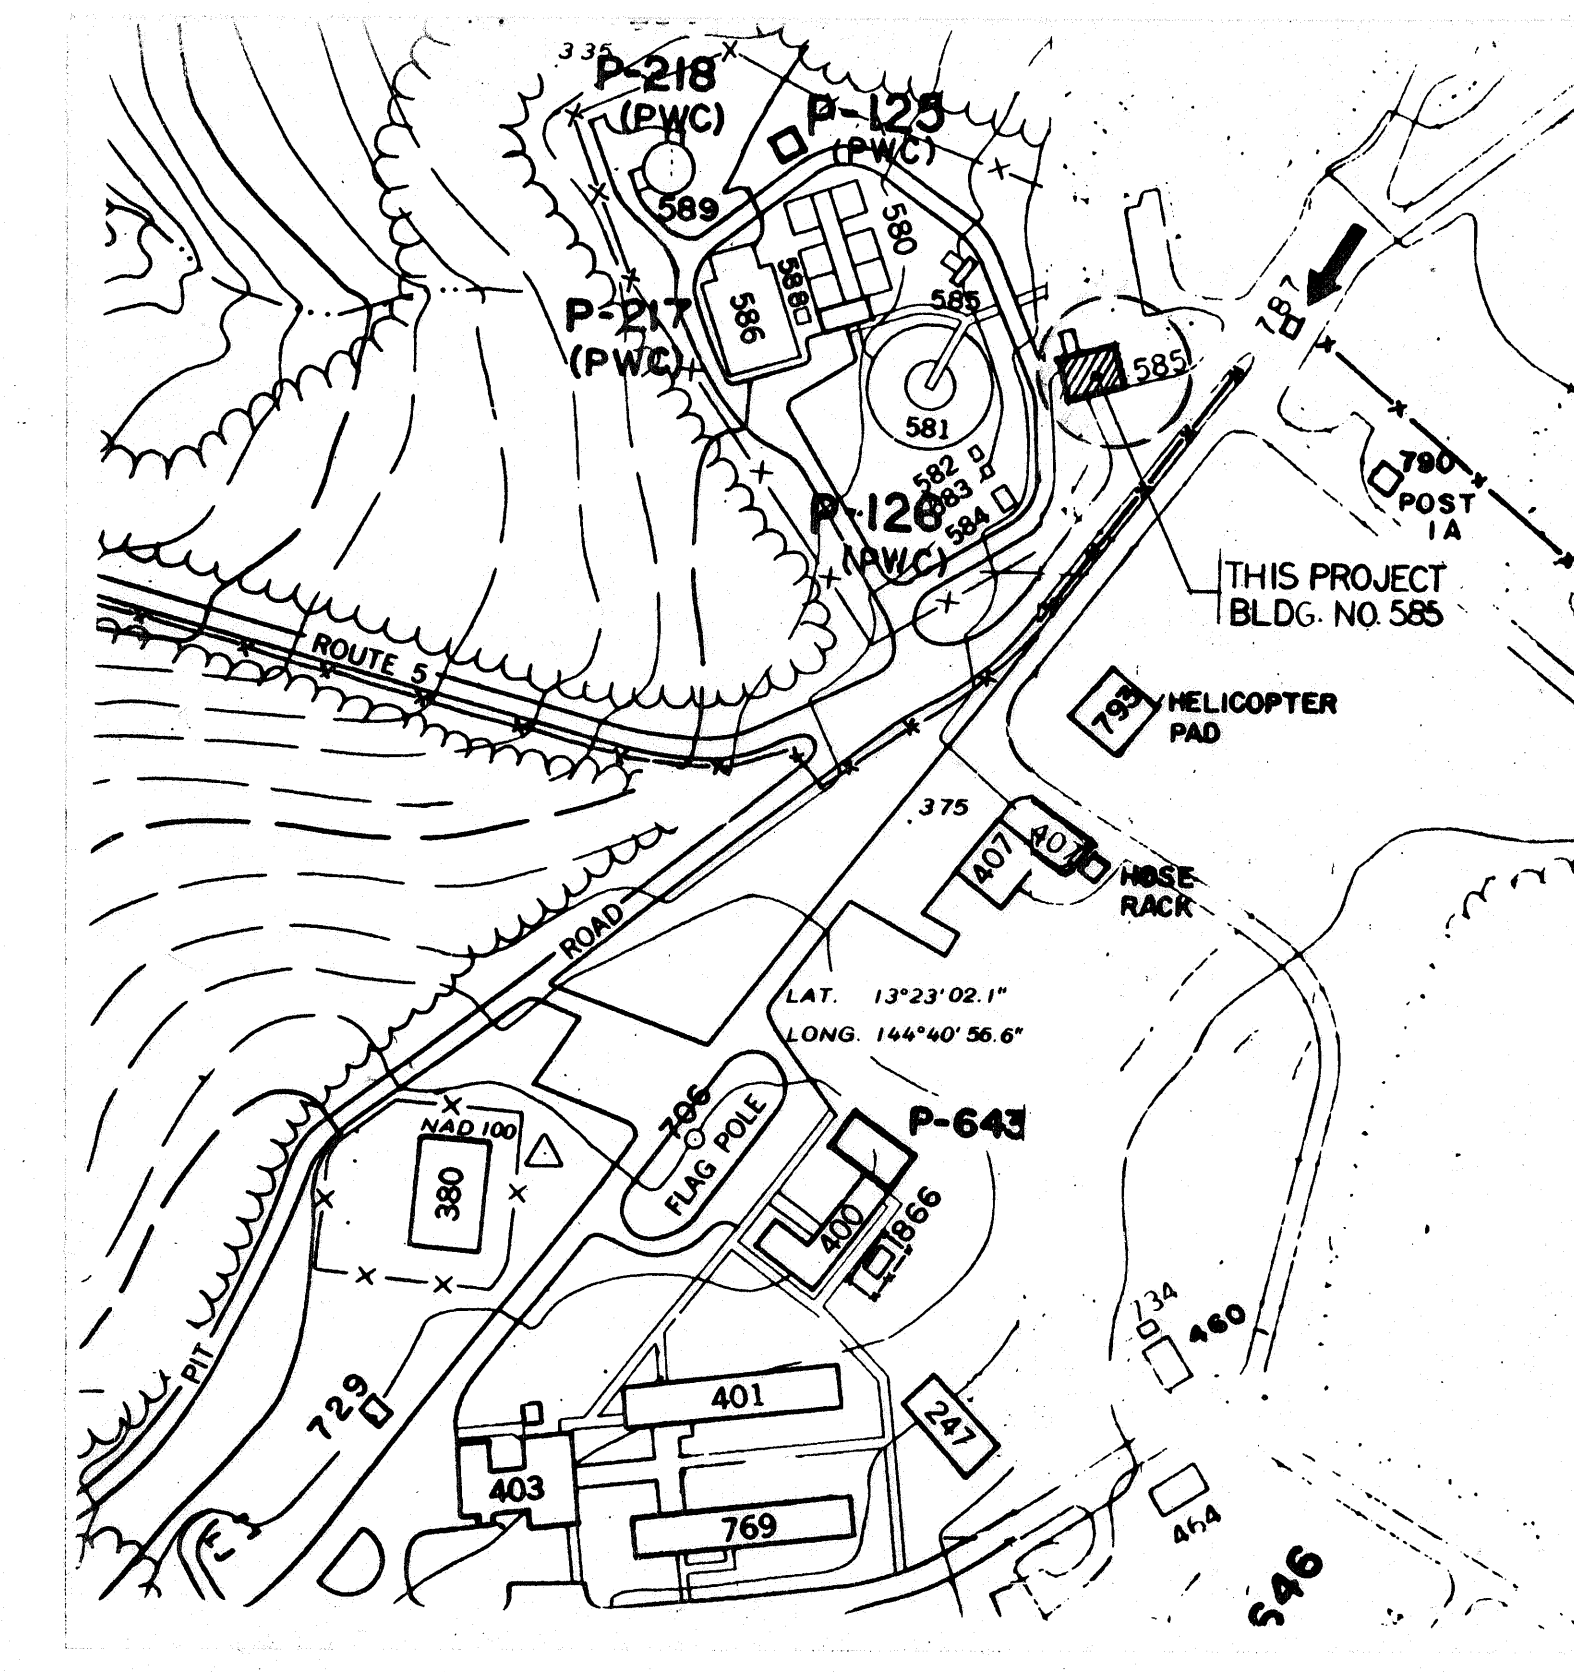


CHEMICAL LABORATORY BLDG. - NAVMAG

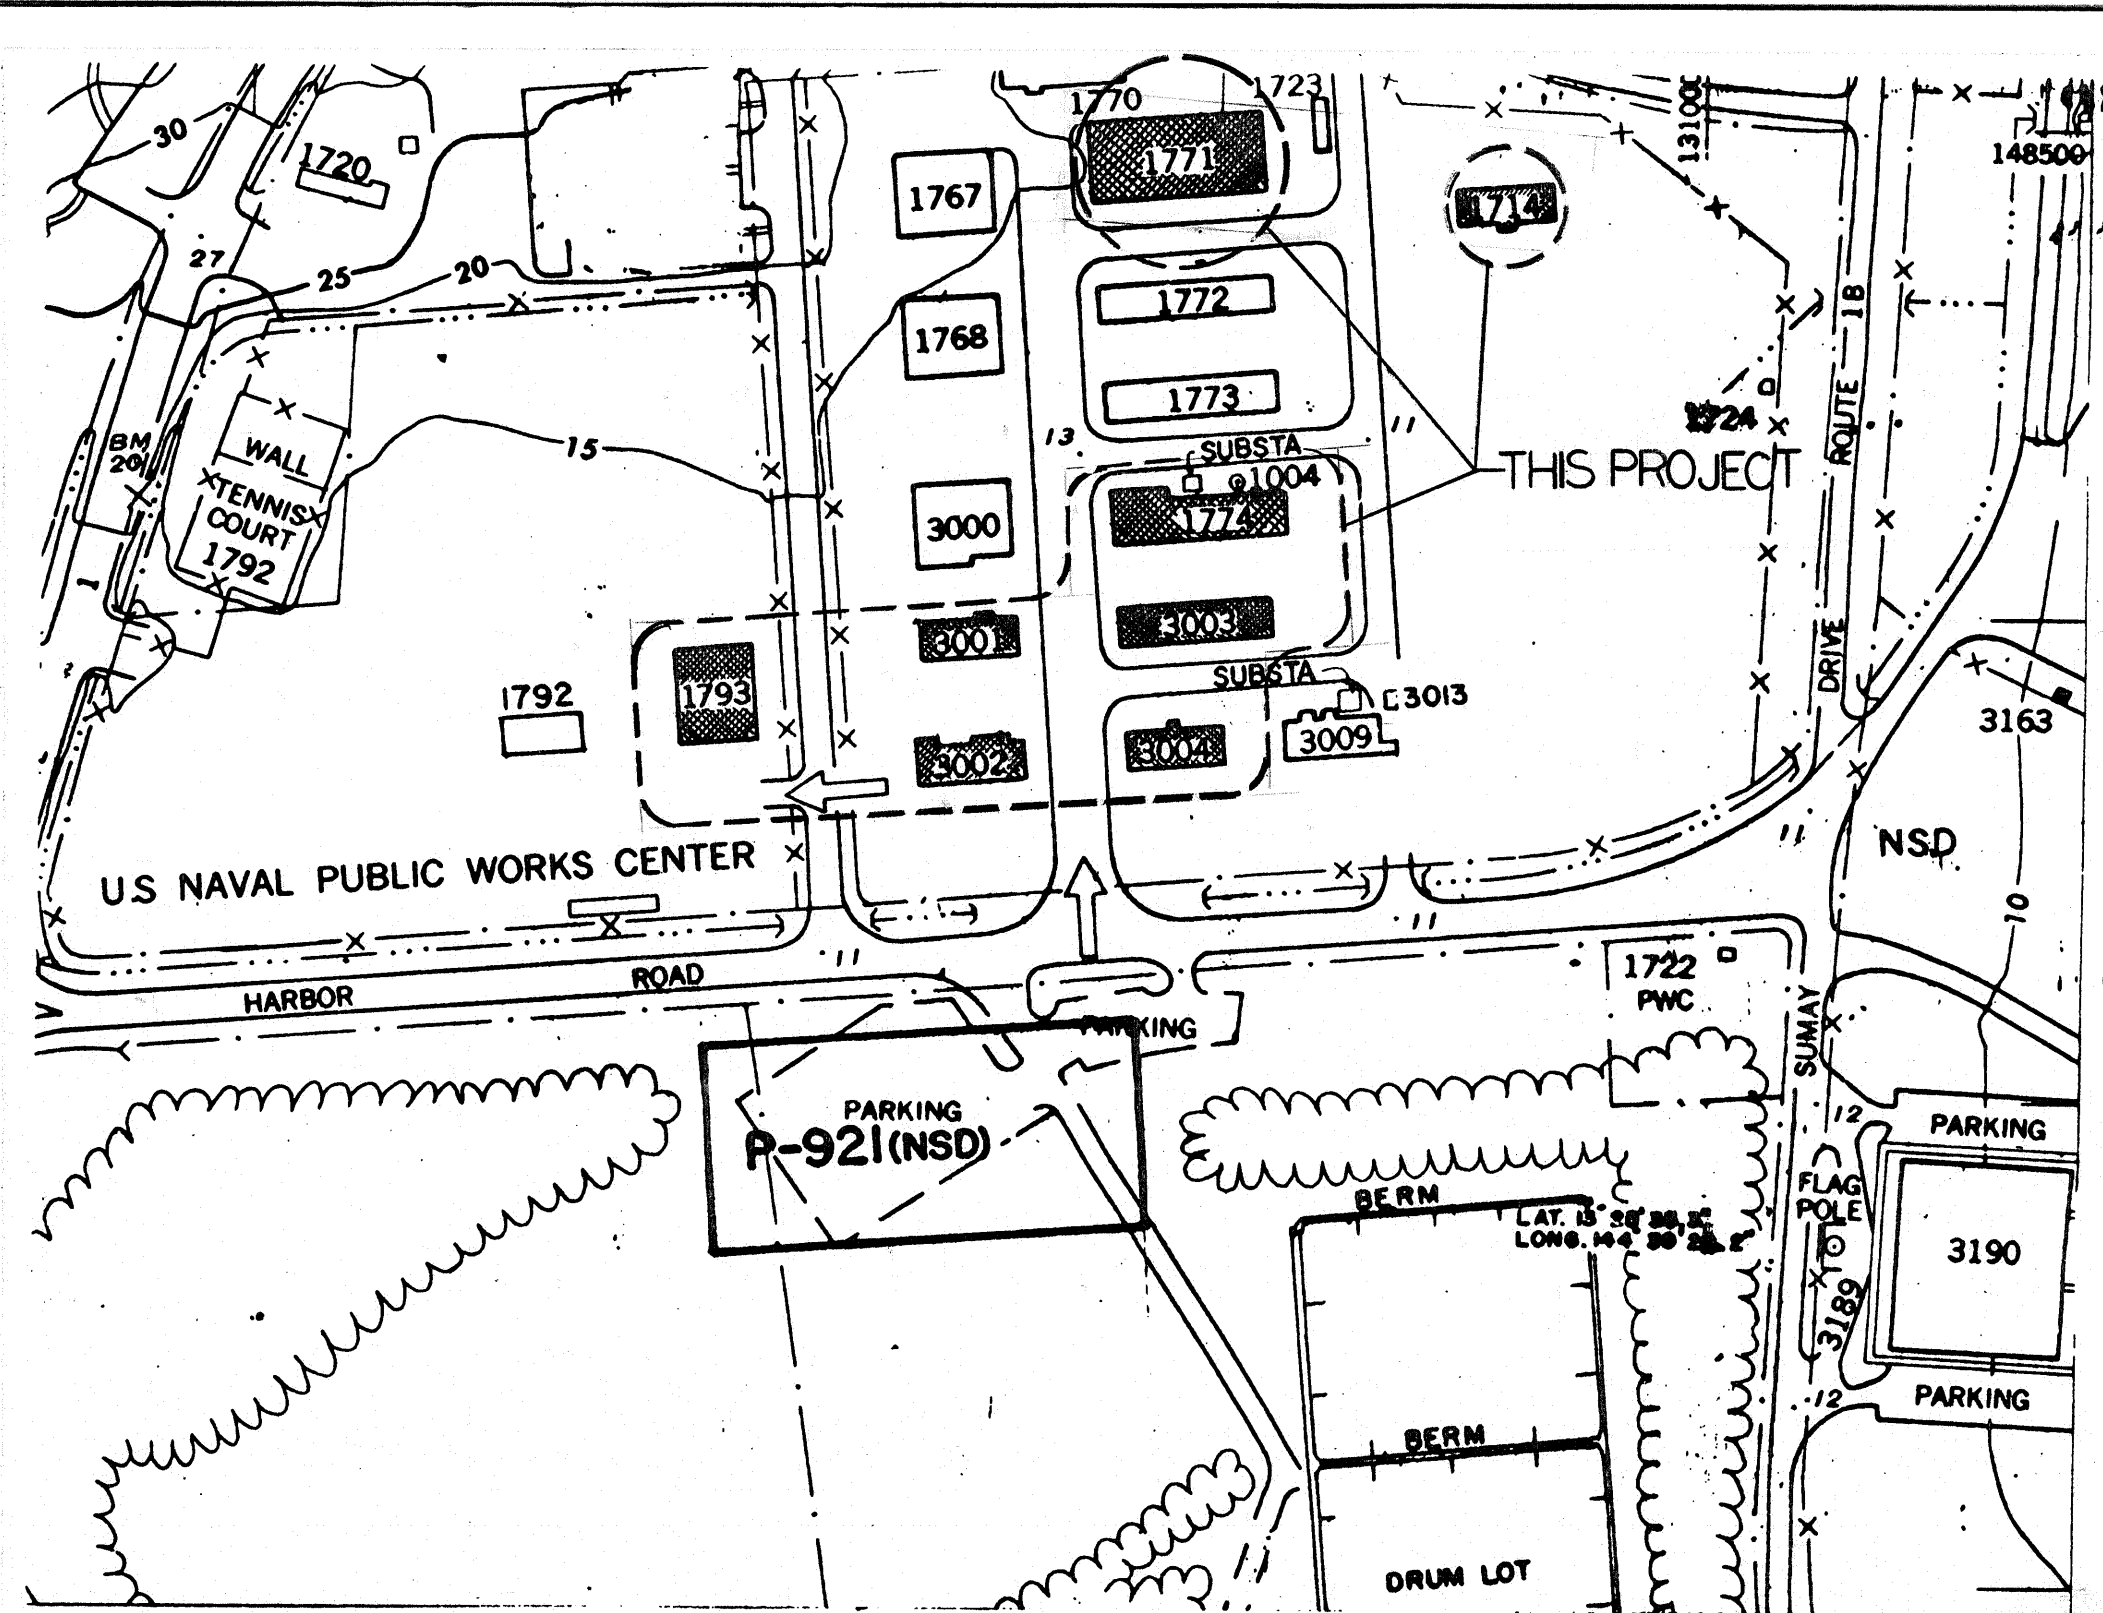

PWC BLDGS. - NAVAL STATION

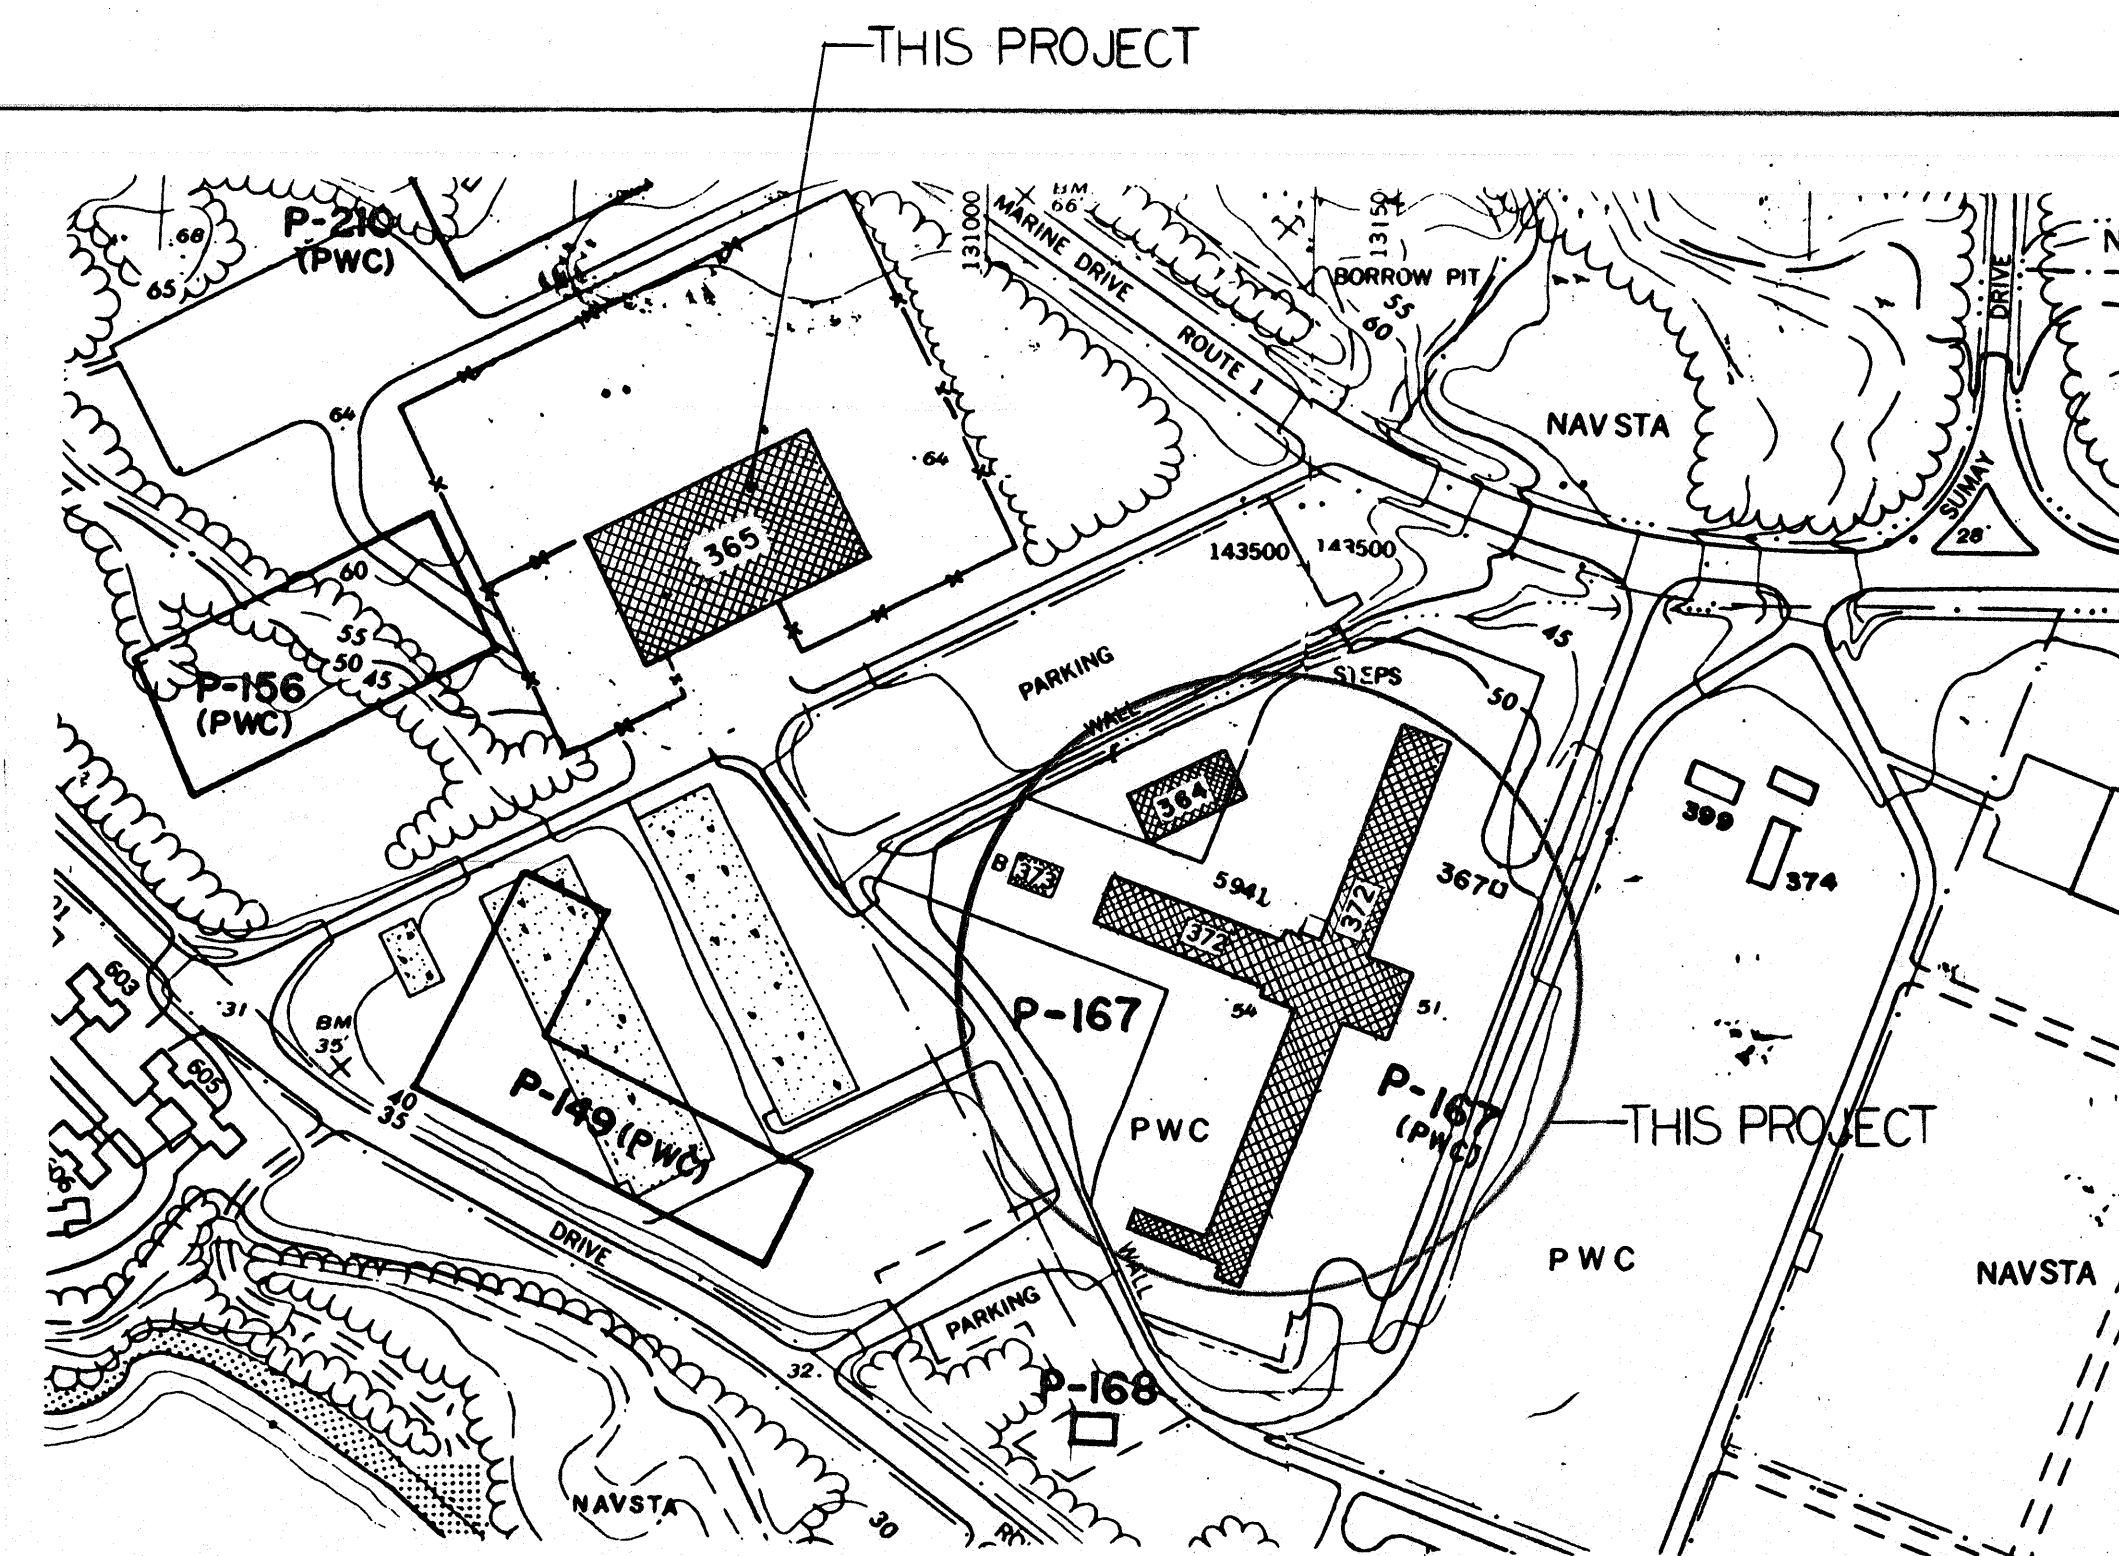

VICINITY MAPS
NOT TO SCALE

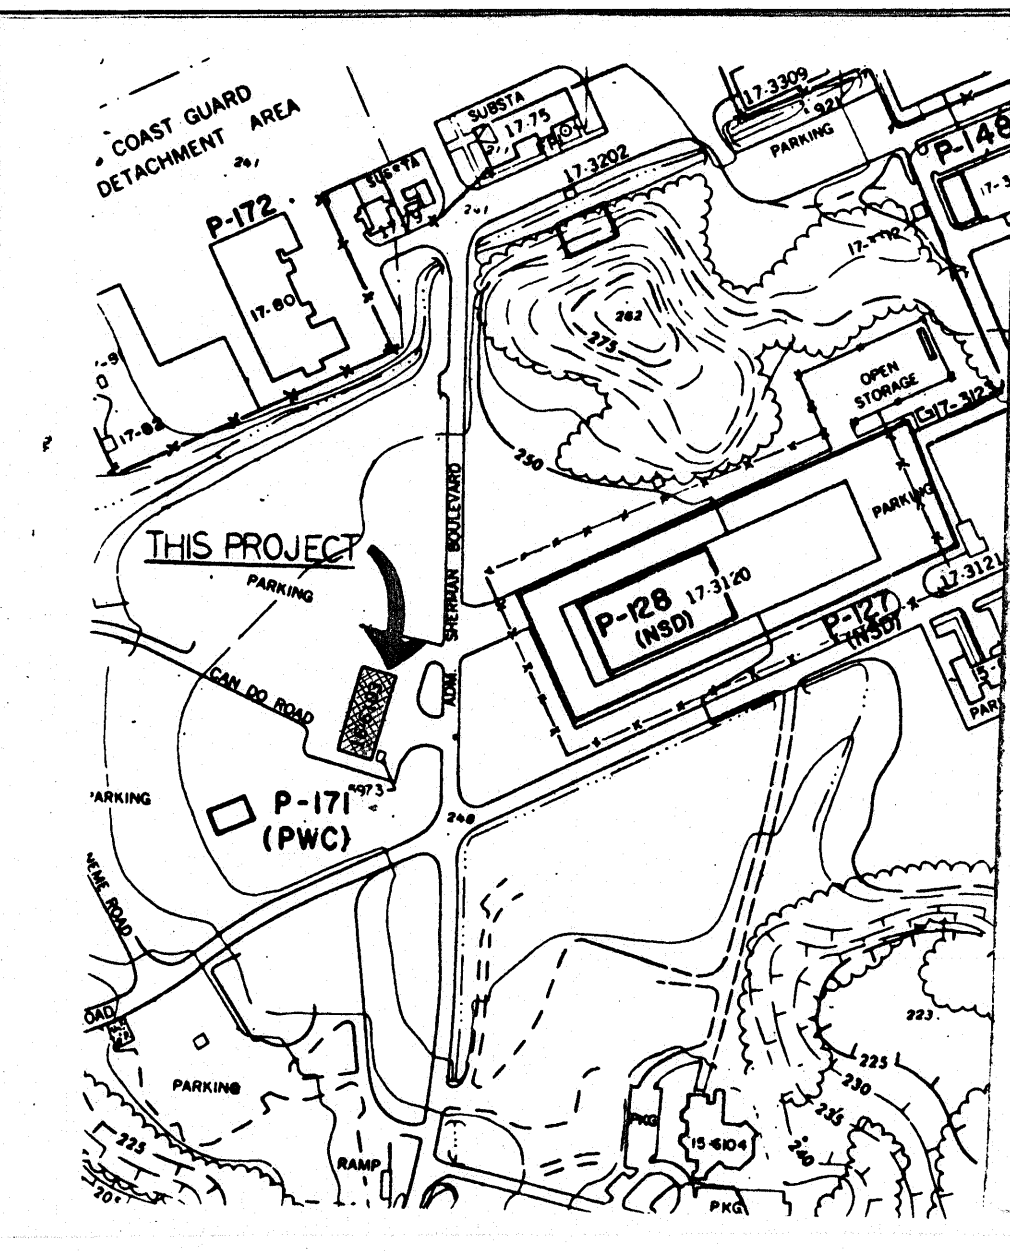

TRANSPORTATION EQUIPMENT BLDG. - NAS

REVISIONS		
SYM	DESCRIPTION	DATE

DEPT OF THE NAVY PUBLIC WORKS CENTER GUAM, M. I.	NAVAFAC OFFICER IN CHARGE OF CONSTRUCTION NAVAL FACILITIES ENGINEERING COMMAND CONTRACTS, MARIANAS GUAM, M. I.	DEPARTMENT OF THE NAVY NAVAL FACILITIES ENGINEERING COMMAND OFFICER IN CHARGE OF CONSTRUCTION NAVAL FACILITIES ENGINEERING COMMAND CONTRACTS, MARIANAS GUAM, M. I.
DES: CDB DR: CDB CHK: h	PWC	GUAM, M. I.
DIV DIR: [Signature]	INSTALL FIRE ALARM SYSTEM AT VARIOUS U. S. NAVY PWC BUILDINGS	
DEPT HEAD: [Signature]	VICINITY MAPS	
SCE: [Signature]		
WR NO: [Signature]		
REVIEWED BY: [Signature]	SIZE: F	CODE IDENT NO: 80091
DIR, DCC ENGINEERING DIV. DATE: [Signature]	NAVAFAC DRAWING NO: 7318367	
APPROVED: [Signature]	CONSTR. CONTR. NO. N62766 89 C 2505	
DCC FOR COMMANDER NAVAFAC DATE: [Signature]	SCALE: N.T.S.	SPEC: 4-89-2505
		SHEET 2 OF 12

11/18/89