




REVISIONS			
NO.	DESCRIPTION	DATE	APPROVED

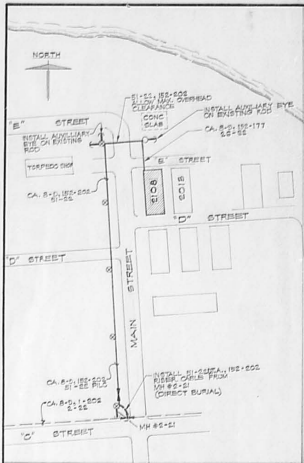

LOCATION PLAN
SCALE: 1" = 100'-0"

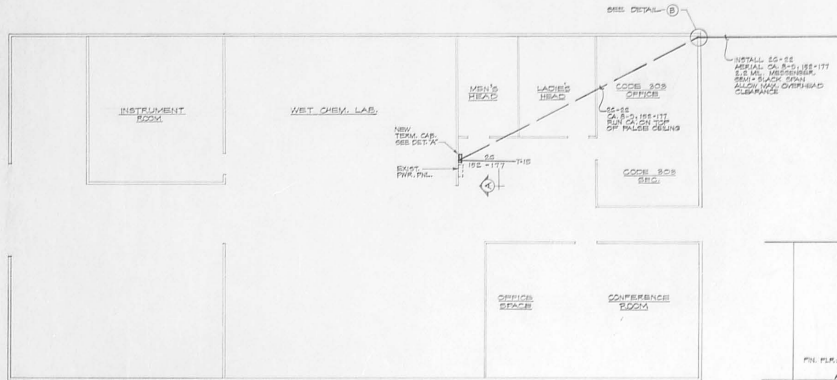

FLOOR PLAN
SCALE: 1/8" = 1'-0"

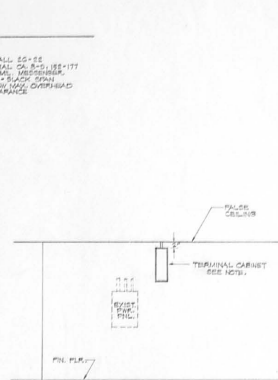


DETAIL - (A)
SCALE: NONE

NOTE:


USE RELIABLE TYPE 555 (ST. 55 PG. 50) PROTECTED CABLE TERMINALS OR EQUIVAL.

LEGEND:

- ⊙ JOINT USE POLE EXISTING
- TELEPHONE POLE EXISTING
- ASY. CABLE TO BE INSTALLED
- - - EXISTING UNDERGROUND CABLE

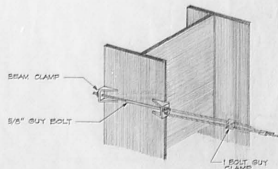

DETAIL - (B)
METHOD OF DEAD-ENDS SUSPENSION STRAND
SCALE: NONE

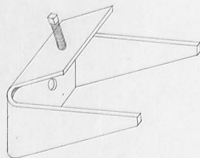

BEAM CLAMP

DESIGNED BY: <i>J. J. Johnson</i> 5/26/62	DEPARTMENT OF THE NAVY - NAVAL FACILITIES ENGINEERING COMMAND
DRAWN BY: <i>Walter</i> 6/1/62	PUBLIC WORKS CENTER
CHECKED BY: <i>Walter</i> 6/1/62	ROOM: <i>NAVAL FACILITIES</i> DRAWING NO.:
BY: <i>Walter</i> 6/1/62	ADDITIONAL CABLE FACILITIES TO BLDG. 2108
DATE: <i>5/26/62</i>	
WR NO. 1800872	
REVISED BY: <i>Walter</i> 6/1/62	DATE: <i>6/1/62</i>
APPROVED BY: <i>Walter</i> 6/1/62	DATE: <i>6/1/62</i>
SCALE: AS SHOWN	SHEET 1 OF 1