


ONE LINE DIAGRAM
NTS

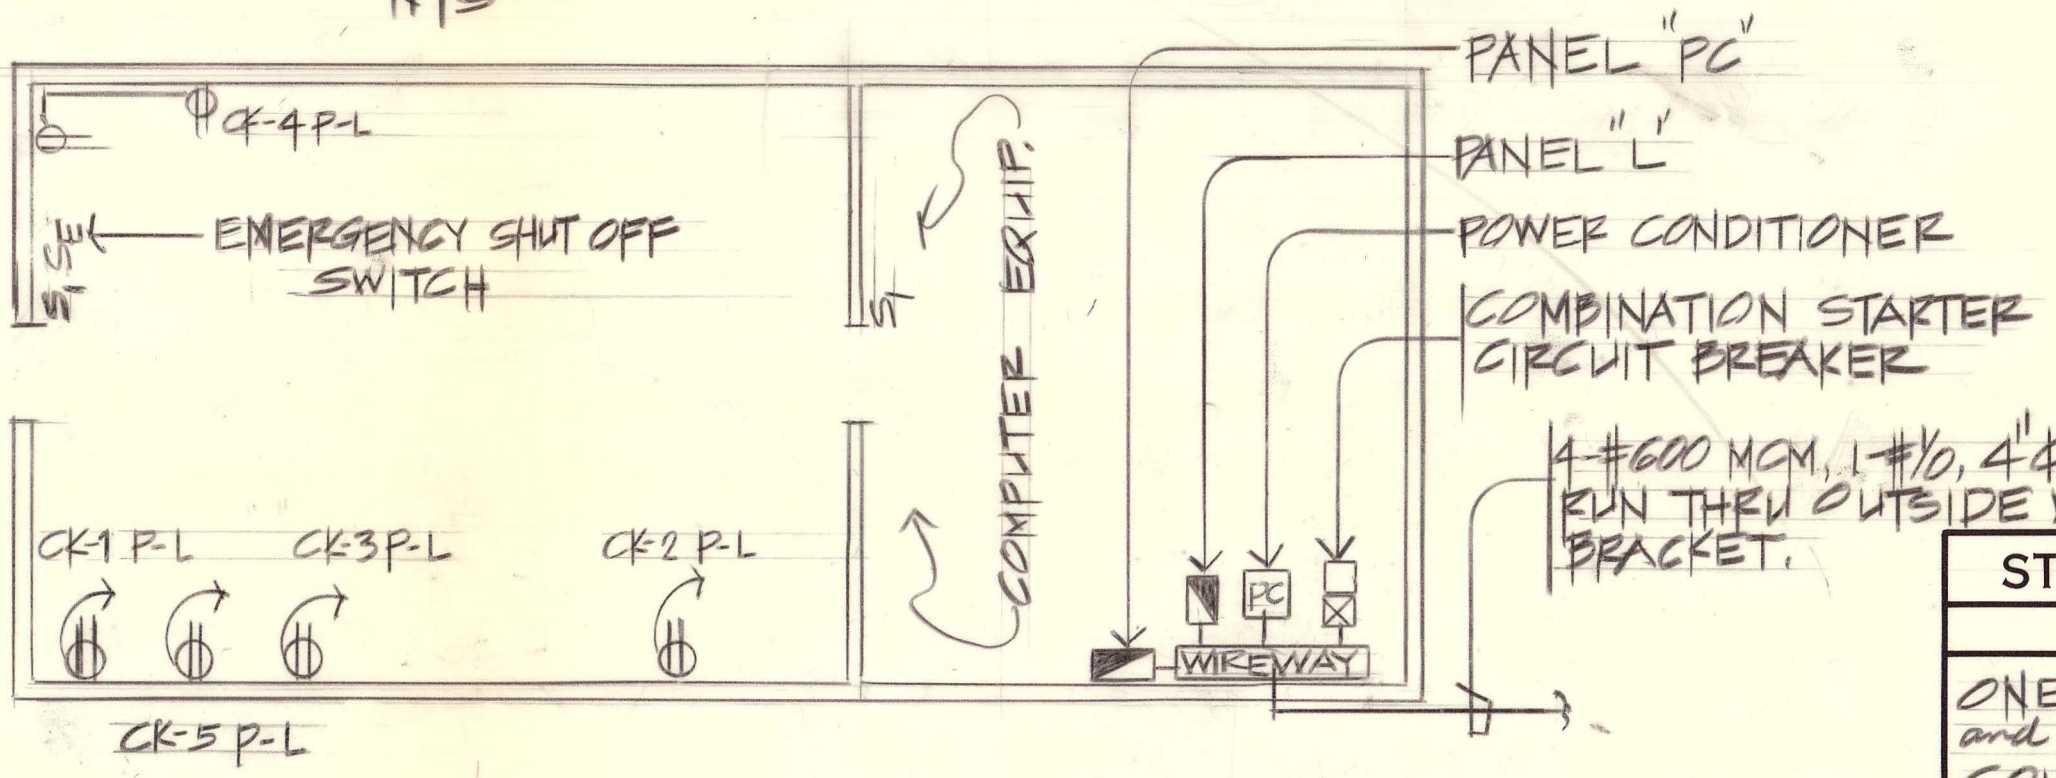

FLOOR and ELECTRICAL PLAN
NTS

STRATEGIC AIR COMMAND		
CIVIL ENGINEERING		
ONE LINE DIAGRAM, FLOOR and ELECTRICAL PLAN, COOP COMPUTER 21000 L/B-5		
DATE 2 MAR 87	PREPARED ROGER N	APPROVED MIKE Z.
SCALE NTS	DRAWING NUMBER	SHEET 1 OF 1